

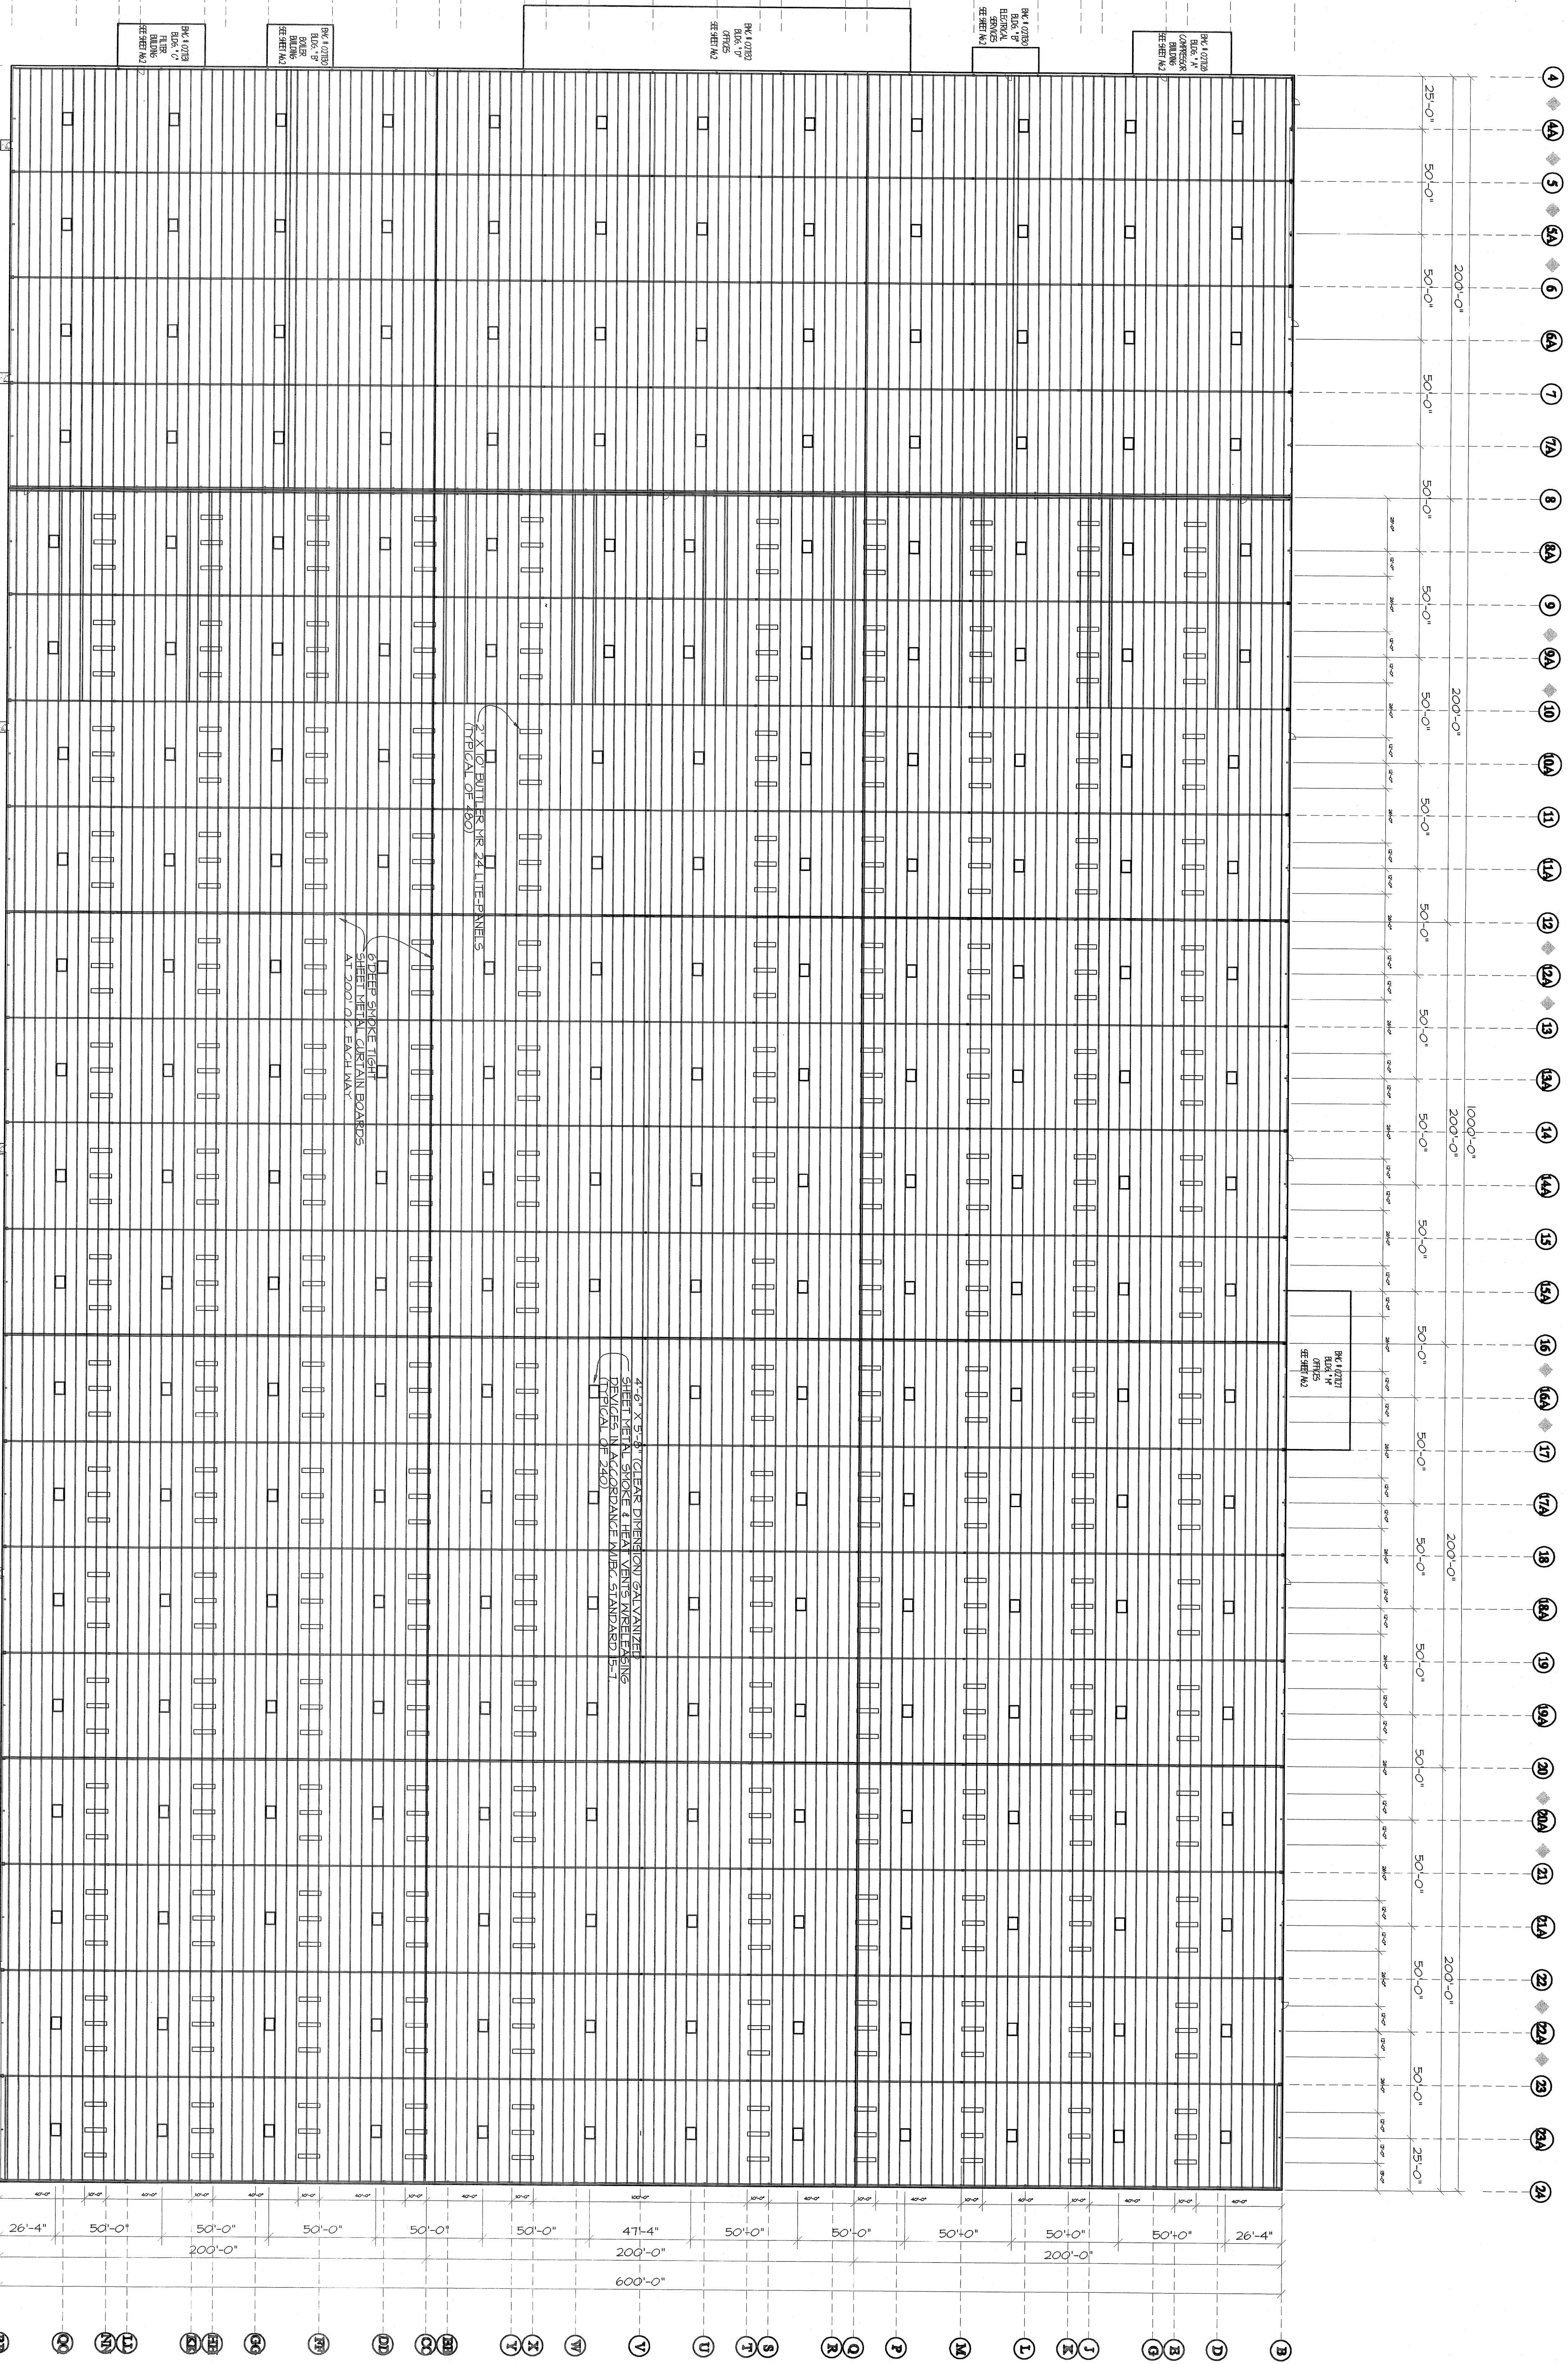


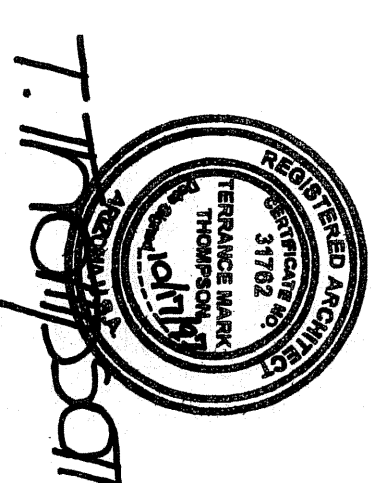

REFLECTED CEILING PLAN

1/32" = 1'-0"

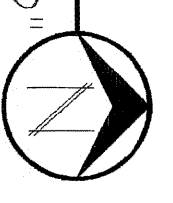

MEADOWCRAFT WAREHOUSE
YUMA COUNTY, ARIZONA

GENERAL REFLECTED CEILING PLAN

SCALE: 1/32" = 1'
DATE: SEPT. 1971
DRAWN BY: W.B.

SHEET 97-038

EDPAIS
Engineering
3026 S. 44th St.
Yuma, Arizona 86406
(928) 344-3088 FAX (928) 341-1078

A6.1